
 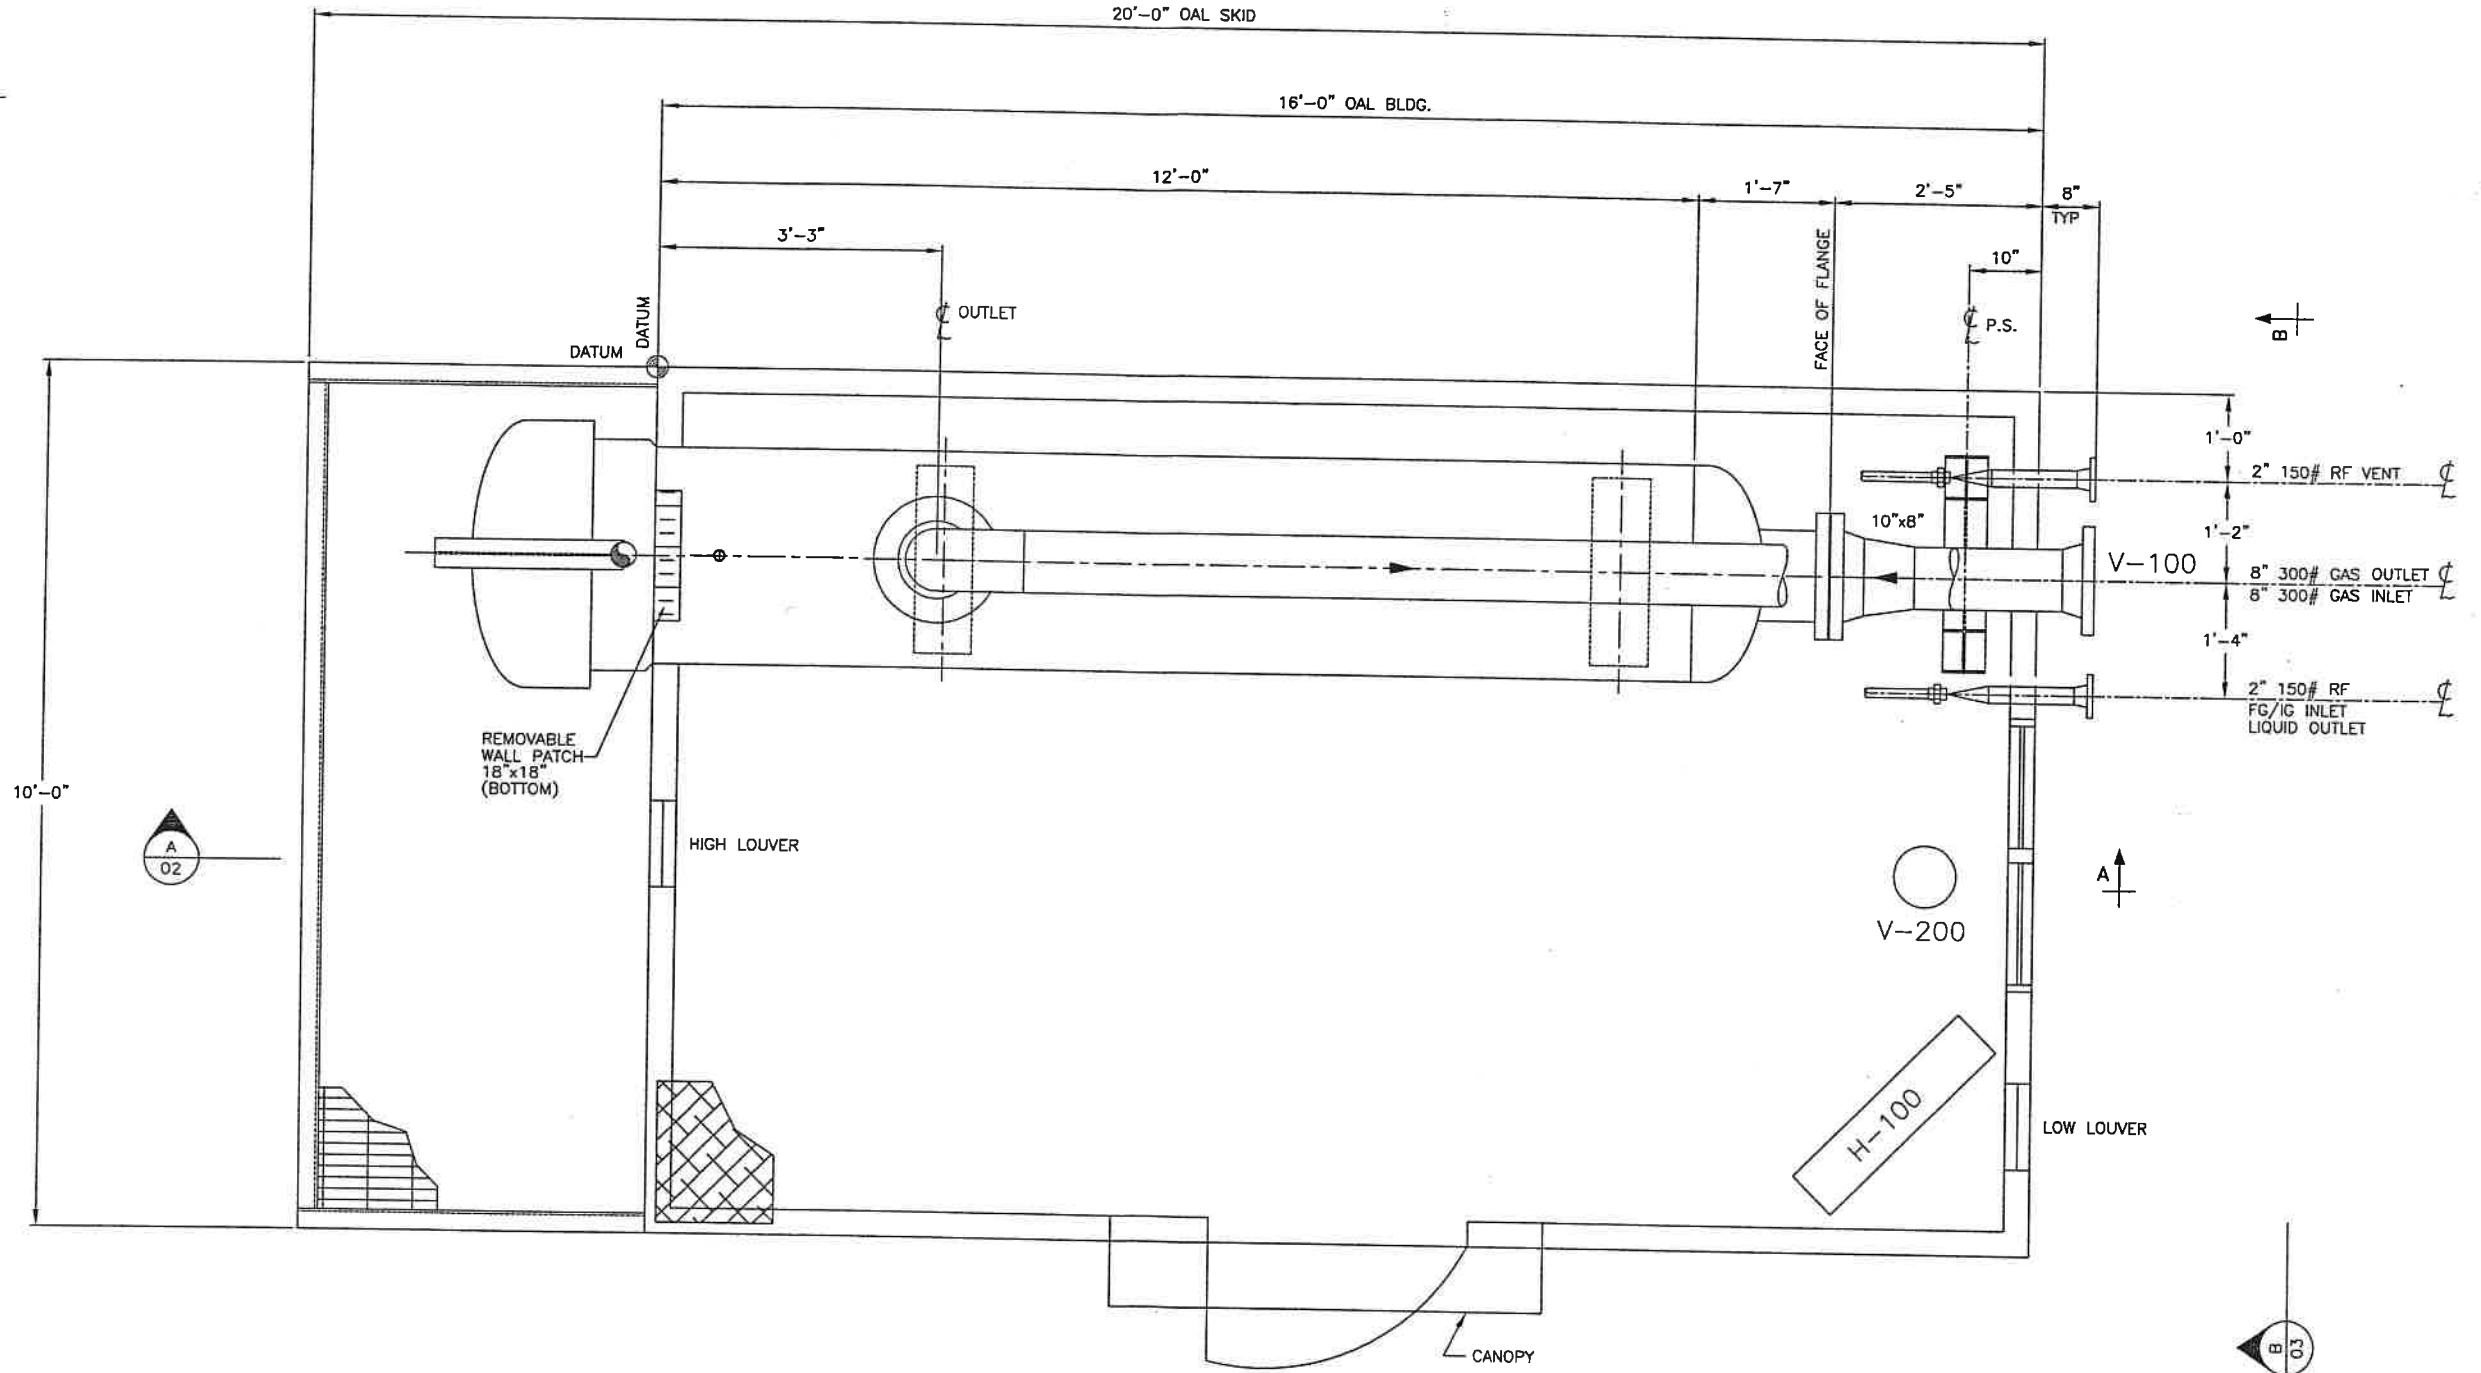




PLAN

PAINTING NOTES:

PREP: SSPC-SP-2
PRIMER: (1) RUSTOLEUM PRIMER
FINISH: (1) COAT RUSTOLEUM ENAMEL LIGHT GREY
OTHER: LIGHT GREY ON PIPING, VESSELS & EQUIPMENT

BUILDING NOTES:

CONSTRUCTION: SELF FRAMING
ROOF TYPE: GABLE
ROOF SLOPE: 3:1
EXT. MATERIAL: PREPAINTED STEEL 22g
EXT. WALL COLOR: TAN, QC-315
EXT. TRIM COLOR: BROWN, QC-228 (& ROOF)
INT. MATERIAL: ALUMINUM 22g
INT. COLOR: PLAIN
WALLS INSULATION: R12
ROOF INSULATION: R12
VAPOR BARRIER: 4 mil
DOORS: (1) 3'x7' c/w PANIC H/W & IWG & CANOPY
WINDOWS: (1) 3'x3' c/w DG SLIDER
VENTS: (2) 12'x12' LOUVRE c/w SLIDER
OTHER: WALL CUTOUT & PATCH

NO.	DESCRIPTION OF REVISION	BY	DATE	CHK'D
1	ISSUED FOR CONSTRUCTION	LV	01/07/02	
0	ISSUED FOR APPROVAL	LV	01/02/02	




CLIENT: DIRECT ENERGY		
DRAWN	BY	DATE
L. VILLAYERDE		DEC 31/01
CHECKED		
APPROVED		

TITLE		30" OD x 12'-0" S/S FILTER SEPARATOR UNIT PIPING LAYOUT JOB# J-01-298	
SCALE	DRAWING NUMBER		
1"=1'-0"	01-298-LAY-01		

1077


02.02.04

FEB 11 2002

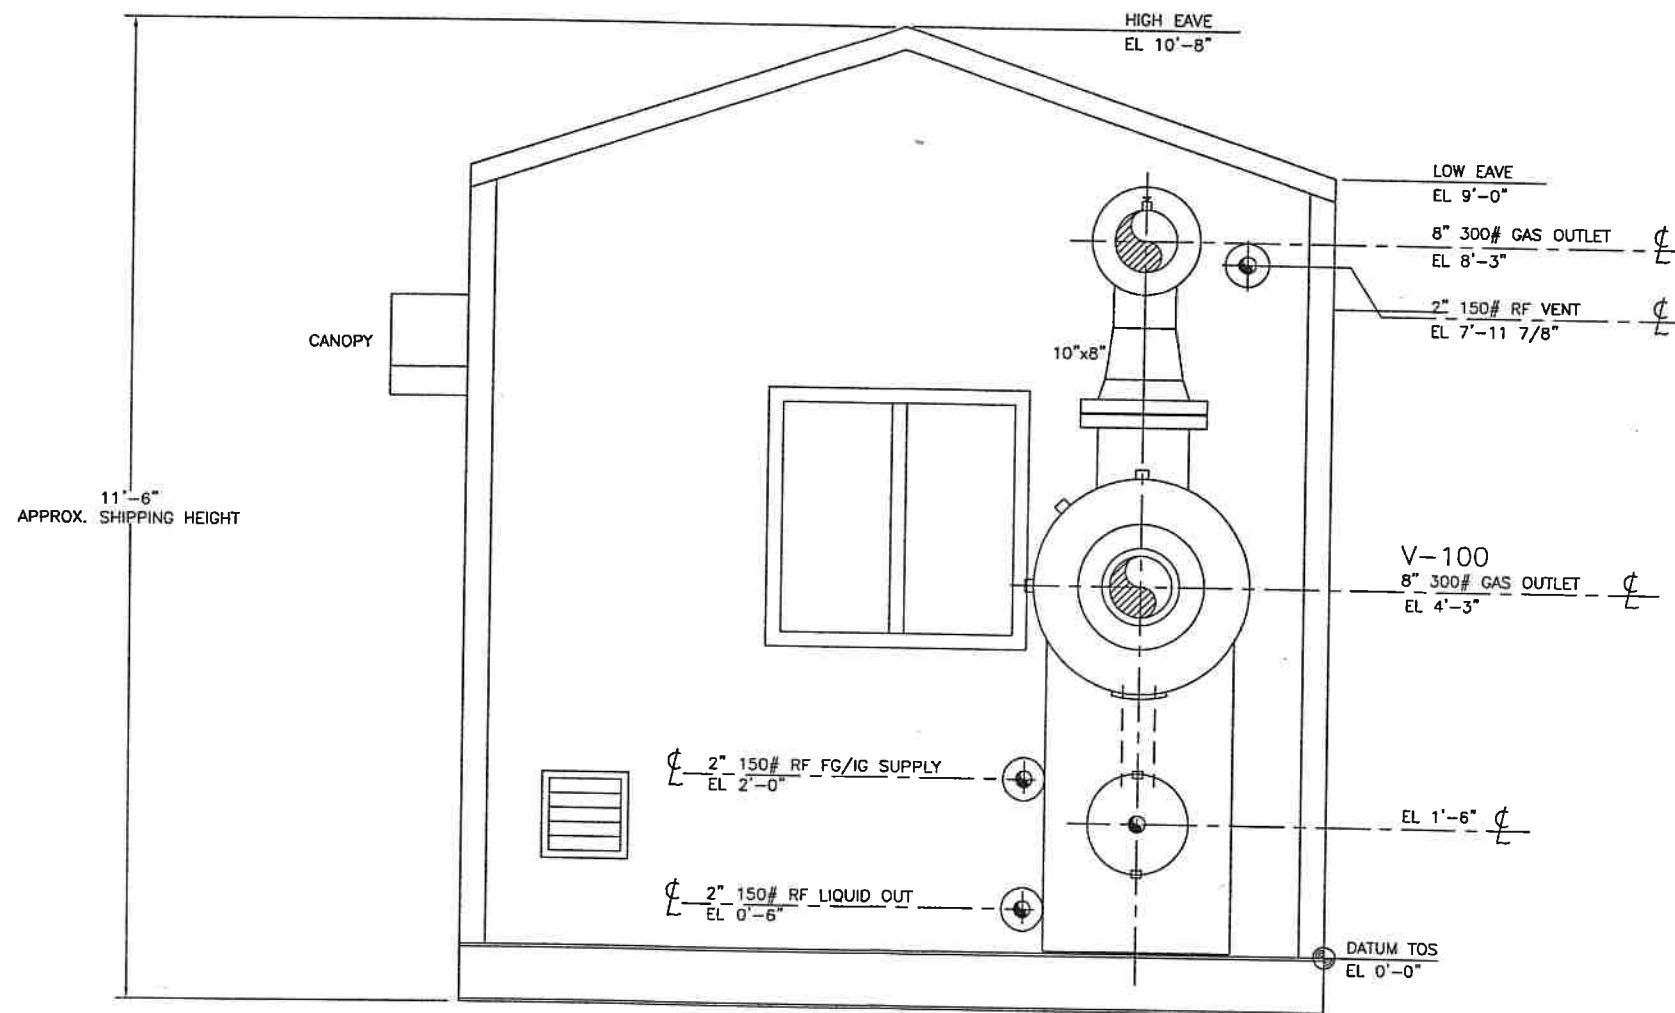

B
01 ELEVATION

NO.	DESCRIPTION OF REVISION	BY	DATE	CHK'D
1	ISSUED FOR CONSTRUCTION	LV	01/07/02	
0	ISSUED FOR APPROVAL	LV	01/02/02	

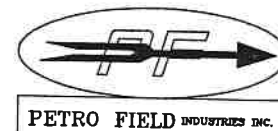


CLIENT: DIRECT ENERGY		
DRAWN	BY	DATE
L. VILLARDE	JAN 02/01	
CHECKED		
APPROVED		


TITLE 30" OD x 12'-0" S/S FILTER SEPARATOR UNIT PIPING ELEVATIONS JOB# J-01-298	
SCALE	DRAWING NUMBER
1"=1'-0"	01-298-LAY-03

107

FEB 11 2002

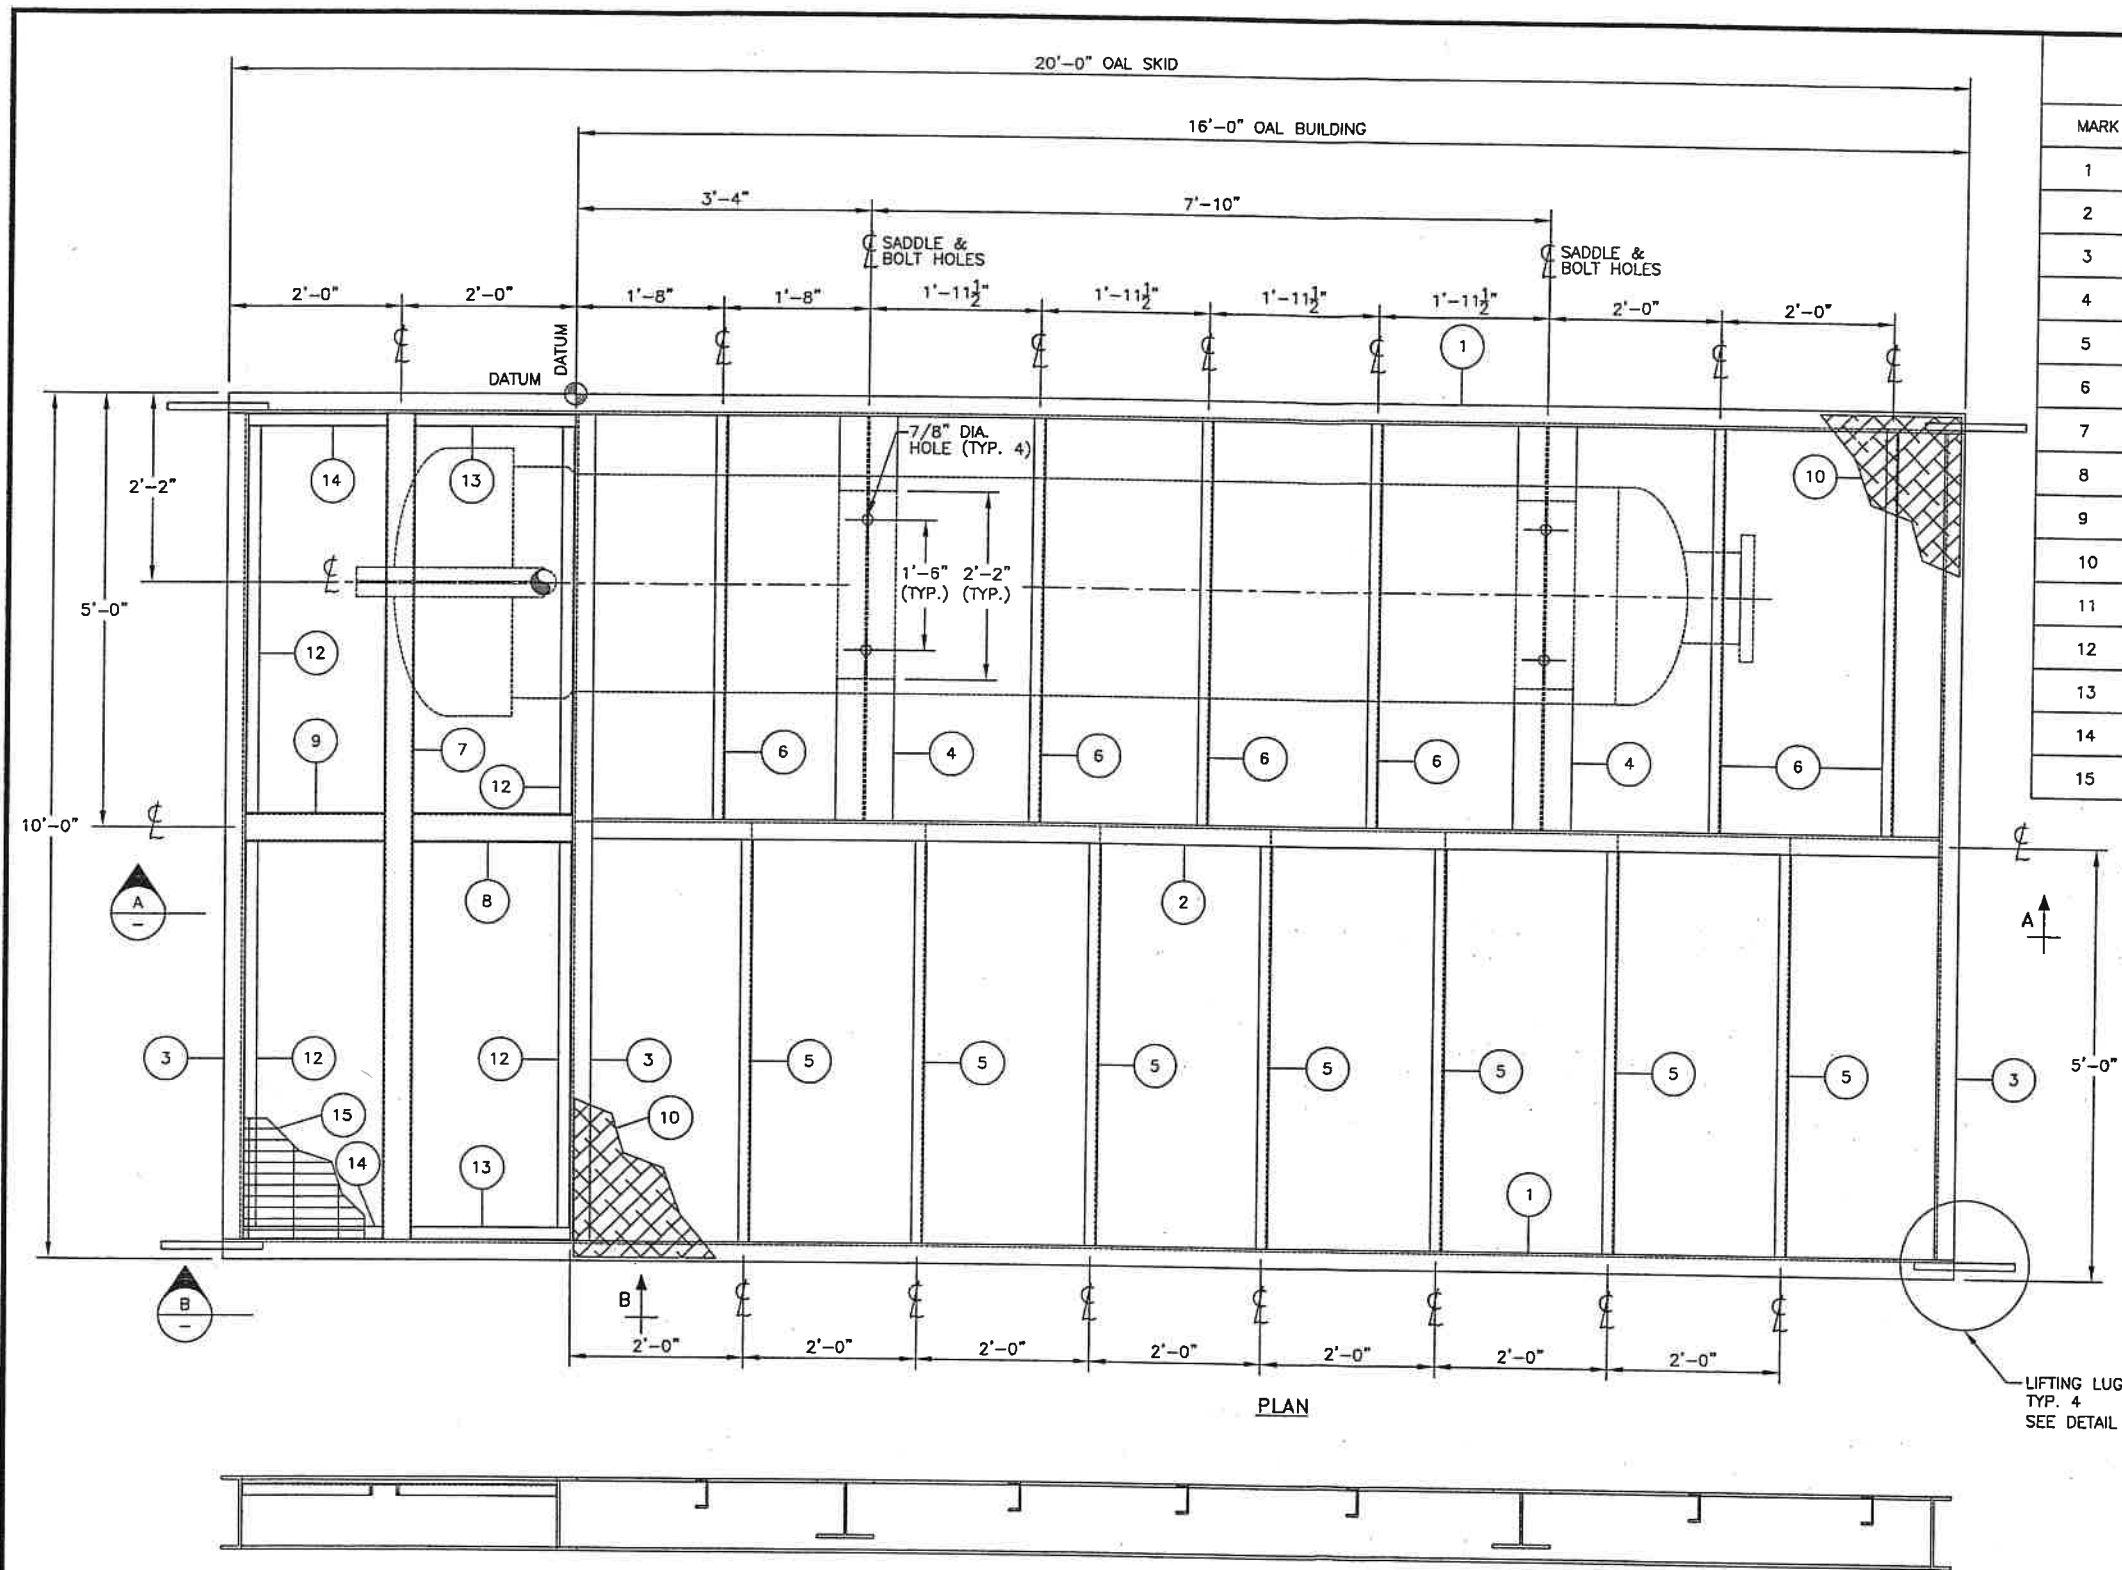


BILL OF MATERIAL		
MARK	QTY	DESCRIPTION
1	2	C10x20 x 20'-0" LG.
2	1	C10x20 x 15'-8 7/8" LG.
3	3	C10x20 x 9'-6 1/2" LG.
4	2	WBx31 x 4'-7 3/4" LG.
5	7	C4x5.4 x 4'-10 3/8" LG.
6	6	C4x5.4 x 4'-7 3/4" LG.
7	1	C4x5.4 x 9'-6 1/2" LG.
8	1	C4x5.4 x 1'-10" LG.
9	1	C4x5.4 x 1'-7 1/4" LG.
10	-	CHECKER PL: 9'-10"x15'-10"x3/16" THK.
11	4	PLATE: 8 7/8"x14"x1" THK. (CTS)
12	4	ANGLE: 1 3/4"x1 3/4"x1/4" THK.x4'-5 1/2" LG.
13	2	ANGLE: 1 3/4"x1 3/4"x1/4" THK.x1'-10" LG.
14	2	ANGLE: 1 3/4"x1 3/4"x1/4" THK.x1'-7 1/4" LG.
15	-	GRATING: 3'-9 1/4"x9'-6 1/2"x1" THK. (CTS)

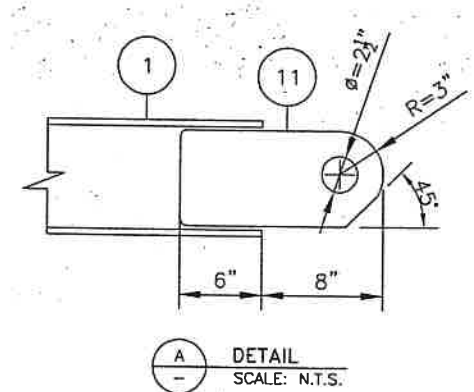

PLAN

SECTION A

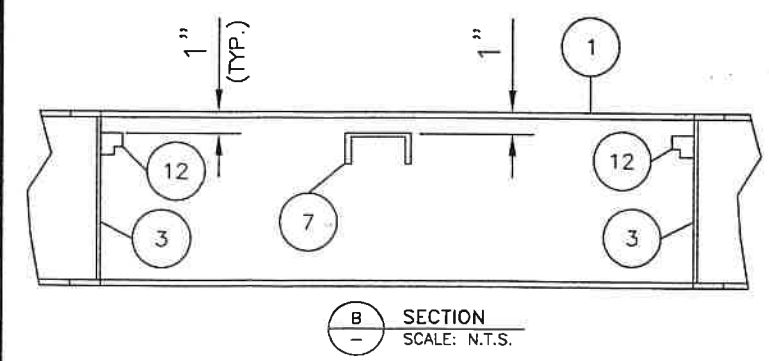

SKID NOTES:
 UNDERSKID INSULATION: NONE
 FIRE RETARDANT COATING: NONE
 OTHER:

NO.	DESCRIPTION OF REVISION	BY	DATE	CHK'D
0	ISSUED FOR CONSTRUCTION	RF	01/07/02	



CLIENT: DIRECT ENERGY		
DRAWN	BY	DATE
CHECKED		
APPROVED		





TITLE		30" OD x 12'-0" S/S FILTER SEPARATOR UNIT SKID LAYOUT JOB# J-01-298
SCALE	DRAWING NUMBER	
1"=1'-0"	01-298-SKD-01	

101

GENERAL NOTES			
DESIGN		PAINTING AND INSULATION	
DESIGN CODE: API SPEC. 12F, ELEVENTH EDITION, NOV. 1, 1994	ADDITIONAL CODES: API SPEC. 850, NINTH EDITION, MAY 1993	INTERNAL FINISH	INSULATION
DESIGN PRESSURE: 4 oz/sq. in. (1.72 MPa)	DESIGN VACUUM: 4 oz/sq. in. (1.72 MPa)	EXTERNAL FINISH	
RADIOGRAPHY: NONE	JOINT EFFICIENCY: N/A		
IMPACT TESTING: N/A	AIR-TEST PRESSURE	CORROSION ALLOWANCE: NONE	
MINIMUM DESIGN METAL TEMPERATURE: -29°C (-20°F)	SERVICE: WATER, OIL, GAS	CAPACITY: 17 cu. m. (100 Bbl) NOM	
OVERALL HEIGHT: 3500mm (11'-6")	WEIGHT: dry: operating: design:	OVERALL WIDTH	
APPURTENANCE & ATTACHMENT WELD DETAILS (n.t.s.)			
COUPLING C3,C4,C6,C7	COUPLING C2,C5,C8	COUPLING C1	NOZZLE T1
COUPLING C1	NOZZLE M1		

NOZZLE SCHEDULE									
MK#	NO.	SIZE	SCH.	RATE	TYPE	INT.	EXT.	REPAID	DESCRIPTION
C1	1	3/16"	-	3000#	FULL ORG.	INT.	HALF	YES	ROOF VENT
C2	1	3/16"	-	3000#	FULL ORG.	INT.	HALF	YES	SECONDARY CONTAINMENT VENT
C3	1	3/16"	-	3000#	FULL ORG.	INT.	HALF	YES	LEVEL SWITCH HIGH
C4	1	3/16"	-	3000#	FULL ORG.	INT.	HALF	YES	SECONDARY CONTAINMENT PUMP OUT
C5	1	3/16"	-	3000#	FULL ORG.	INT.	HALF	YES	PUMP OUT w/DOWNCOMER
C6	1	3/16"	-	3000#	FULL ORG.	INT.	HALF	YES	INLET
C7	1	3/16"	-	3000#	FULL ORG.	INT.	HALF	YES	LEAK DETECTION
C8	1	3/16"	-	3000#	FULL ORG.	INT.	HALF	YES	GAUGE BOARD
C9	1	3/16"	-	3000#	FULL ORG.	INT.	HALF	YES	
T1	1	3/16"	-	FAB'D				YES	THEFT HATCH
M1	1	3/16"	-	FAB'D				YES	ROOF MANWAY

MATERIAL LIST			
MK#	QTY.	DESCRIPTION	WT.
1	1	OUTER TANK SHELL	
2	1	INNER TANK SHELL	
3	1	HEAT TUBE	
4	1	VENTING TUBES (THREE)	
5	1	CATADYNE HEATER 12x24 w/VENT HOOD AND PIPE	
6	1	HEATER CABINET	
7	1	LADDER	
8	1	LIFTING LUGS	
9	1	NAMEPLATE	
10	1	THEFT HATCH (4 oz PRESS. 0.4 oz VAC.)	
11			
12			
13			
14			
15			
16			
17			
18			
19			
20			
21			
22			
23			
24			
25			
26			
27			
28			
29			
30			
31			
32			
33			
34			
35			
36			
37			
38			
39			
40			
41			
42			
43			

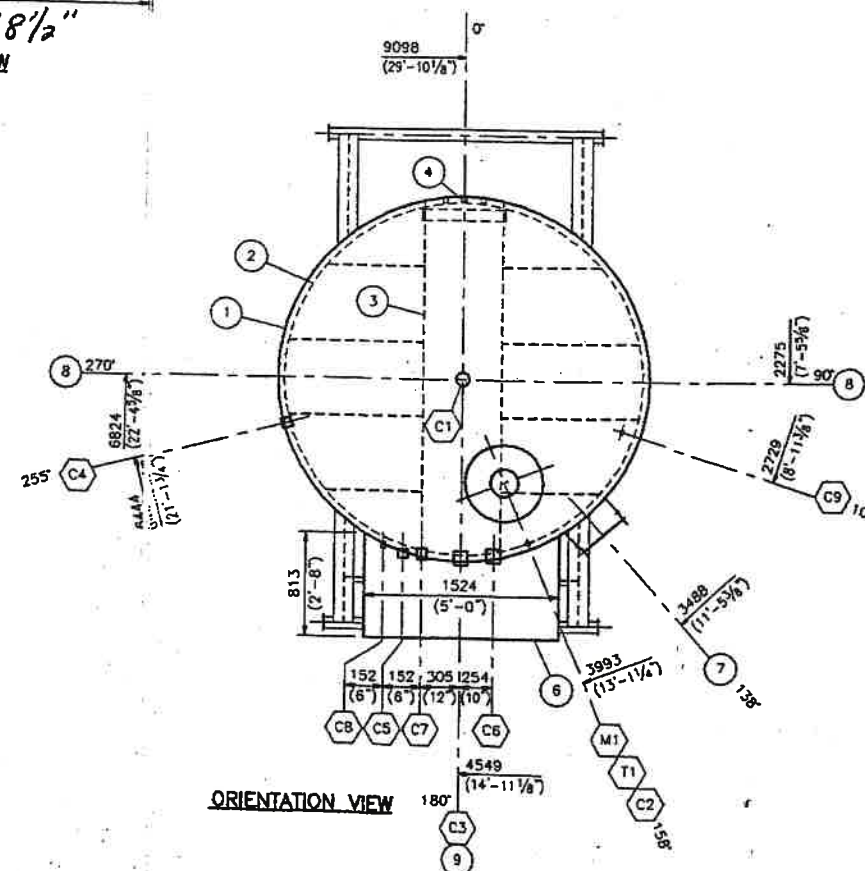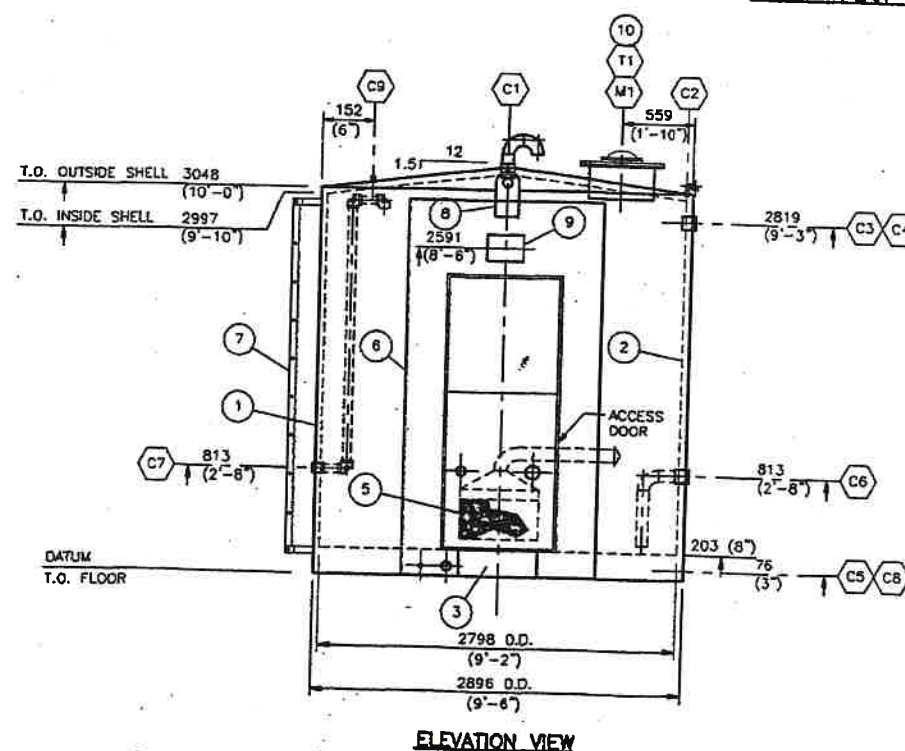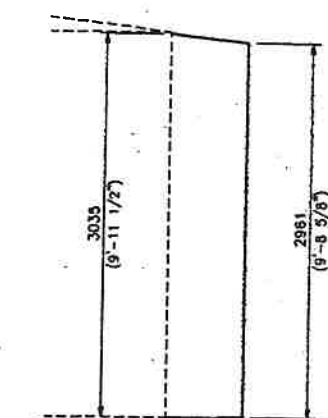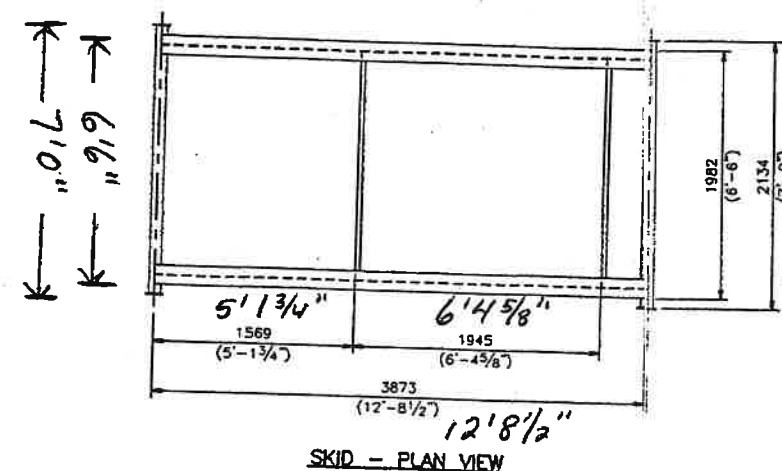

WELD DETAILS	
SHELL JOINT - VERTICAL	SHELL JOINT - HORIZONTAL
SHELL TO FLOOR	SHELL TO ROOF
FLOOR JOINT	ROOF JOINT

- NOTES
- ALL FLANGE RATINGS TO BE ANSI B16.5 LATEST EDITION.
 - FLANGE AND BOLT HOLES TO STRADDLE PRINCIPLE CENTERLINES.
 - INSIDE EDGES OF NOZZLE NECKS, INSPECTION OPENINGS, AND MANWAYS SHALL BE ROUNDED TO A RADIUS OF 1/4" MIN. OR ONE HALF THE WALL THICKNESS IF THE PIPE WALL IS LESS THAN 1/2".
 - ALL DIMENSIONS ARE IN MILLIMETERS. DIMENSIONS IN BRACKETS ARE FOR REFERENCE ONLY.
 - ALL NOZZLE PROJECTIONS ARE MEASURED ALONG NOZZLE CENTERLINE.

								FILE NO.
								1401
								DRAWN
								CAF
								CHECKED
								APPROVED
NUMBER	TITLE	A	14/0/02/00	ISSUED FOR APPROVAL		CAF		
		NO.	DATE	DESCRIPTION		BY	APP'D	ORIGINATING DEPT.
	REFERENCE DRAWINGS			REVISIONS				

Wilco Industries Ltd.
NEILBURG, SASK.

DOUBLE WALLED TANK WITH SKID
17 cu.m. (100 BBL)
2896mm DIA x 3048mm HIGH
9'-6" DIA x 10'-0" HIGH

FEB 11 2002

WILCO

SCALE
1 : 30
DATE
14/02/00
FILE
1401T0
DRAWING NO.
T-1401-D101A
REV